


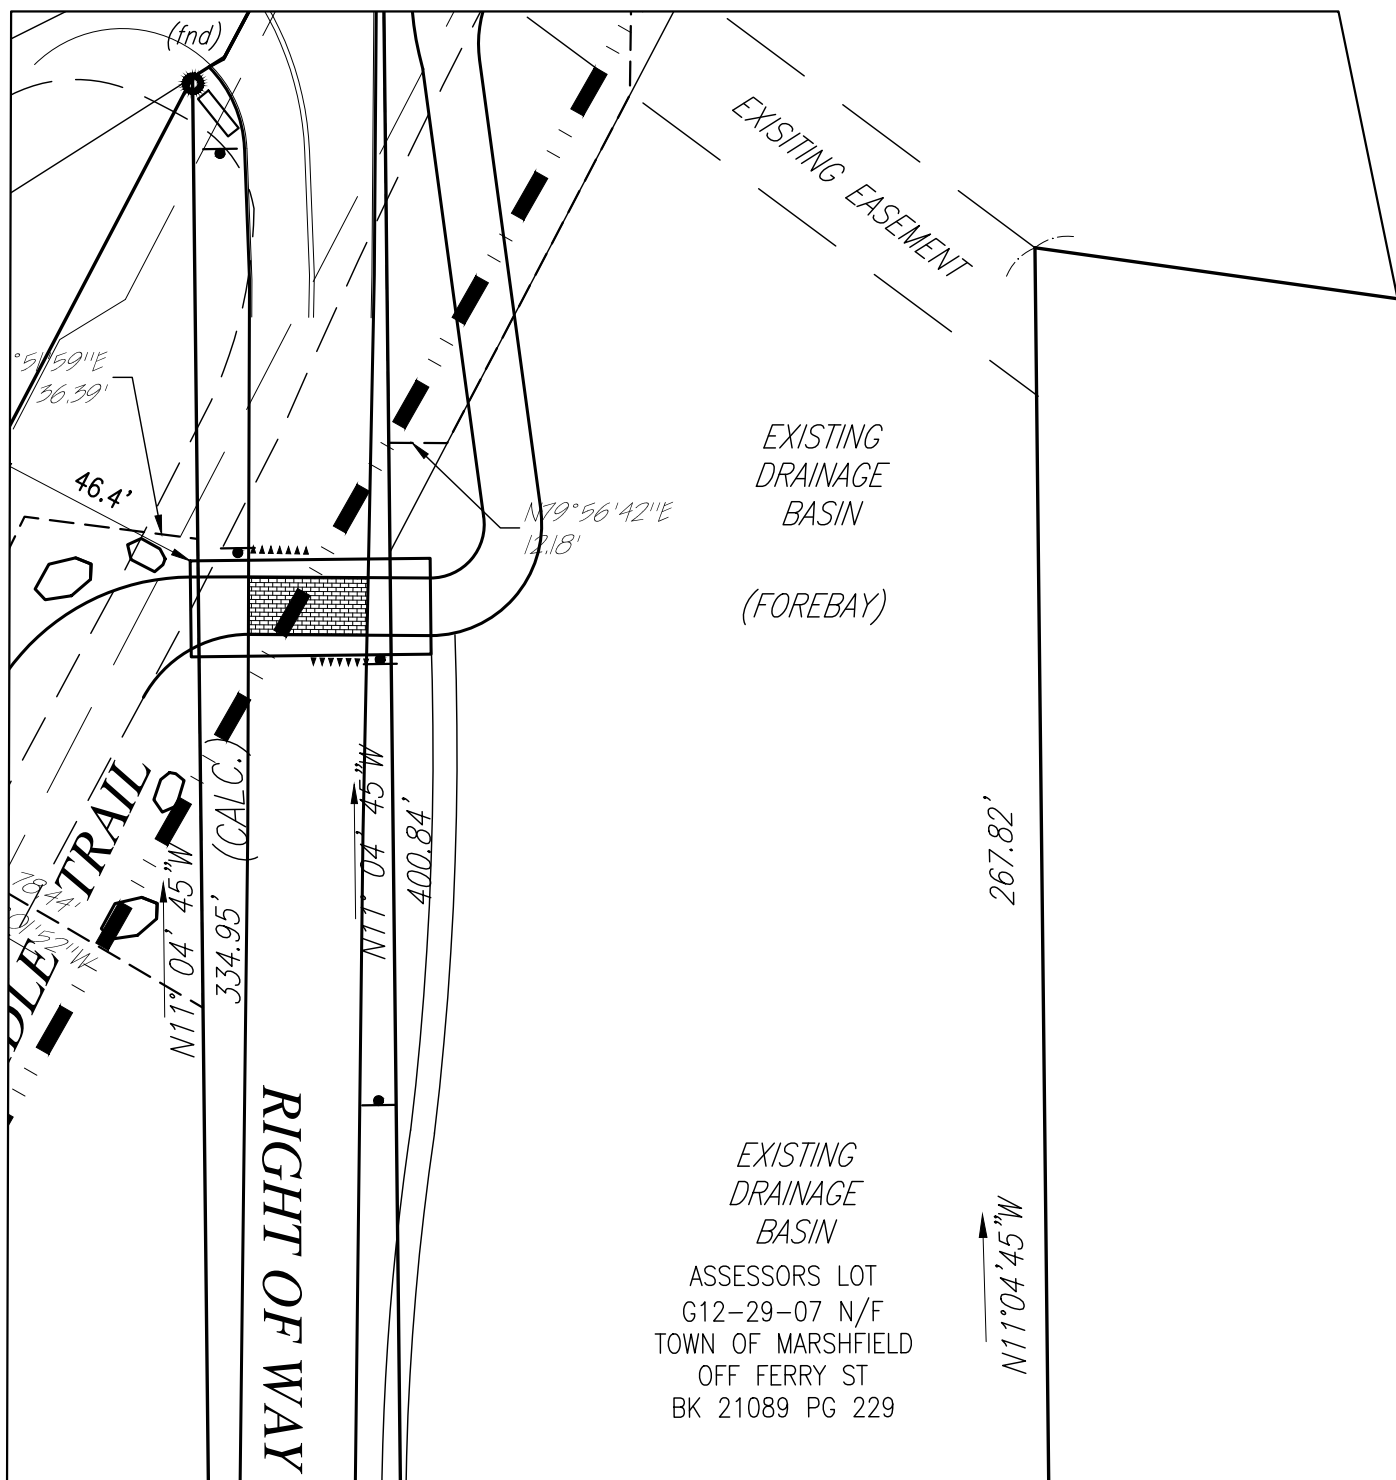


Luminaire Schedule									
Symbol	Qty	Label	Arrangement	Description	Tag	LLF	Luminaire Lumens	Luminaire Watts	Total Watts
●	1	AURORA 50W-3KK-519-TYPE V	Single		P5	0.970	5477	54.7	54.7
●	5	AURORA 50W-35K-TYPE II W SHIELD	Single		P2S	0.970	3843	53	265
●	9	AURORA 50W-35K-519-TYPE III	Single		P3	0.970	5878	54.6	491.4
●	21	AURORA 50W-35K-TYPE IV W SHIELD	Single		P4S	0.970	3695	53	1113

ALL POLES ARE 12 FEET. OVERALL HEIGHT IS 14 FEET.

AURORA SERIES

AREA LIGHTING - POST TOP



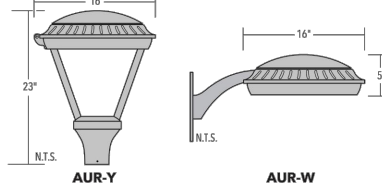

AUR-Y
AUR-W

SPECIFICATIONS

LUMINAIRE All aluminum construction.

DRIVER Electronic LED driver, 120-277V.
Option: 480V Driver, Dimming control 0-10V.

ELECTRICAL All components UL recognized. Luminaire shipped complete & ready to install.

FINISH Powder coat - Standard colors are Black, White, Dark Green & Dark Bronze. Custom colors available, consult factory.
All exposed hardware shall be stainless-steel.

FEATURES + BENEFITS


- Industry leading LED systems
- High efficiency & energy savings
- Environmentally friendly
- Reliable & low-maintenance
- 7-year limited warranty
- UL Listed electrical components
- Suitable for wet locations

ORDER INFORMATION

EXAMPLE: AUR-W 50W 54 08T II W PT-CC-HSS

SYMBOL	WATTS	COLOR TEMP	TYPE	OPTIC	FINISH	OPTION
AUR-Y	50	3000K	TYPE II	TYPE II	08T	PT-CC-HSS
AUR-W	50	3000K	TYPE II	TYPE II	08T	PT-CC-HSS

PH: +1 321 892 0000 9018 E. Washington Blvd.
Fax: +1 321 892 1983 Covington, CA 94626
Email: info@echo-lighting.com www.echo-lighting.com

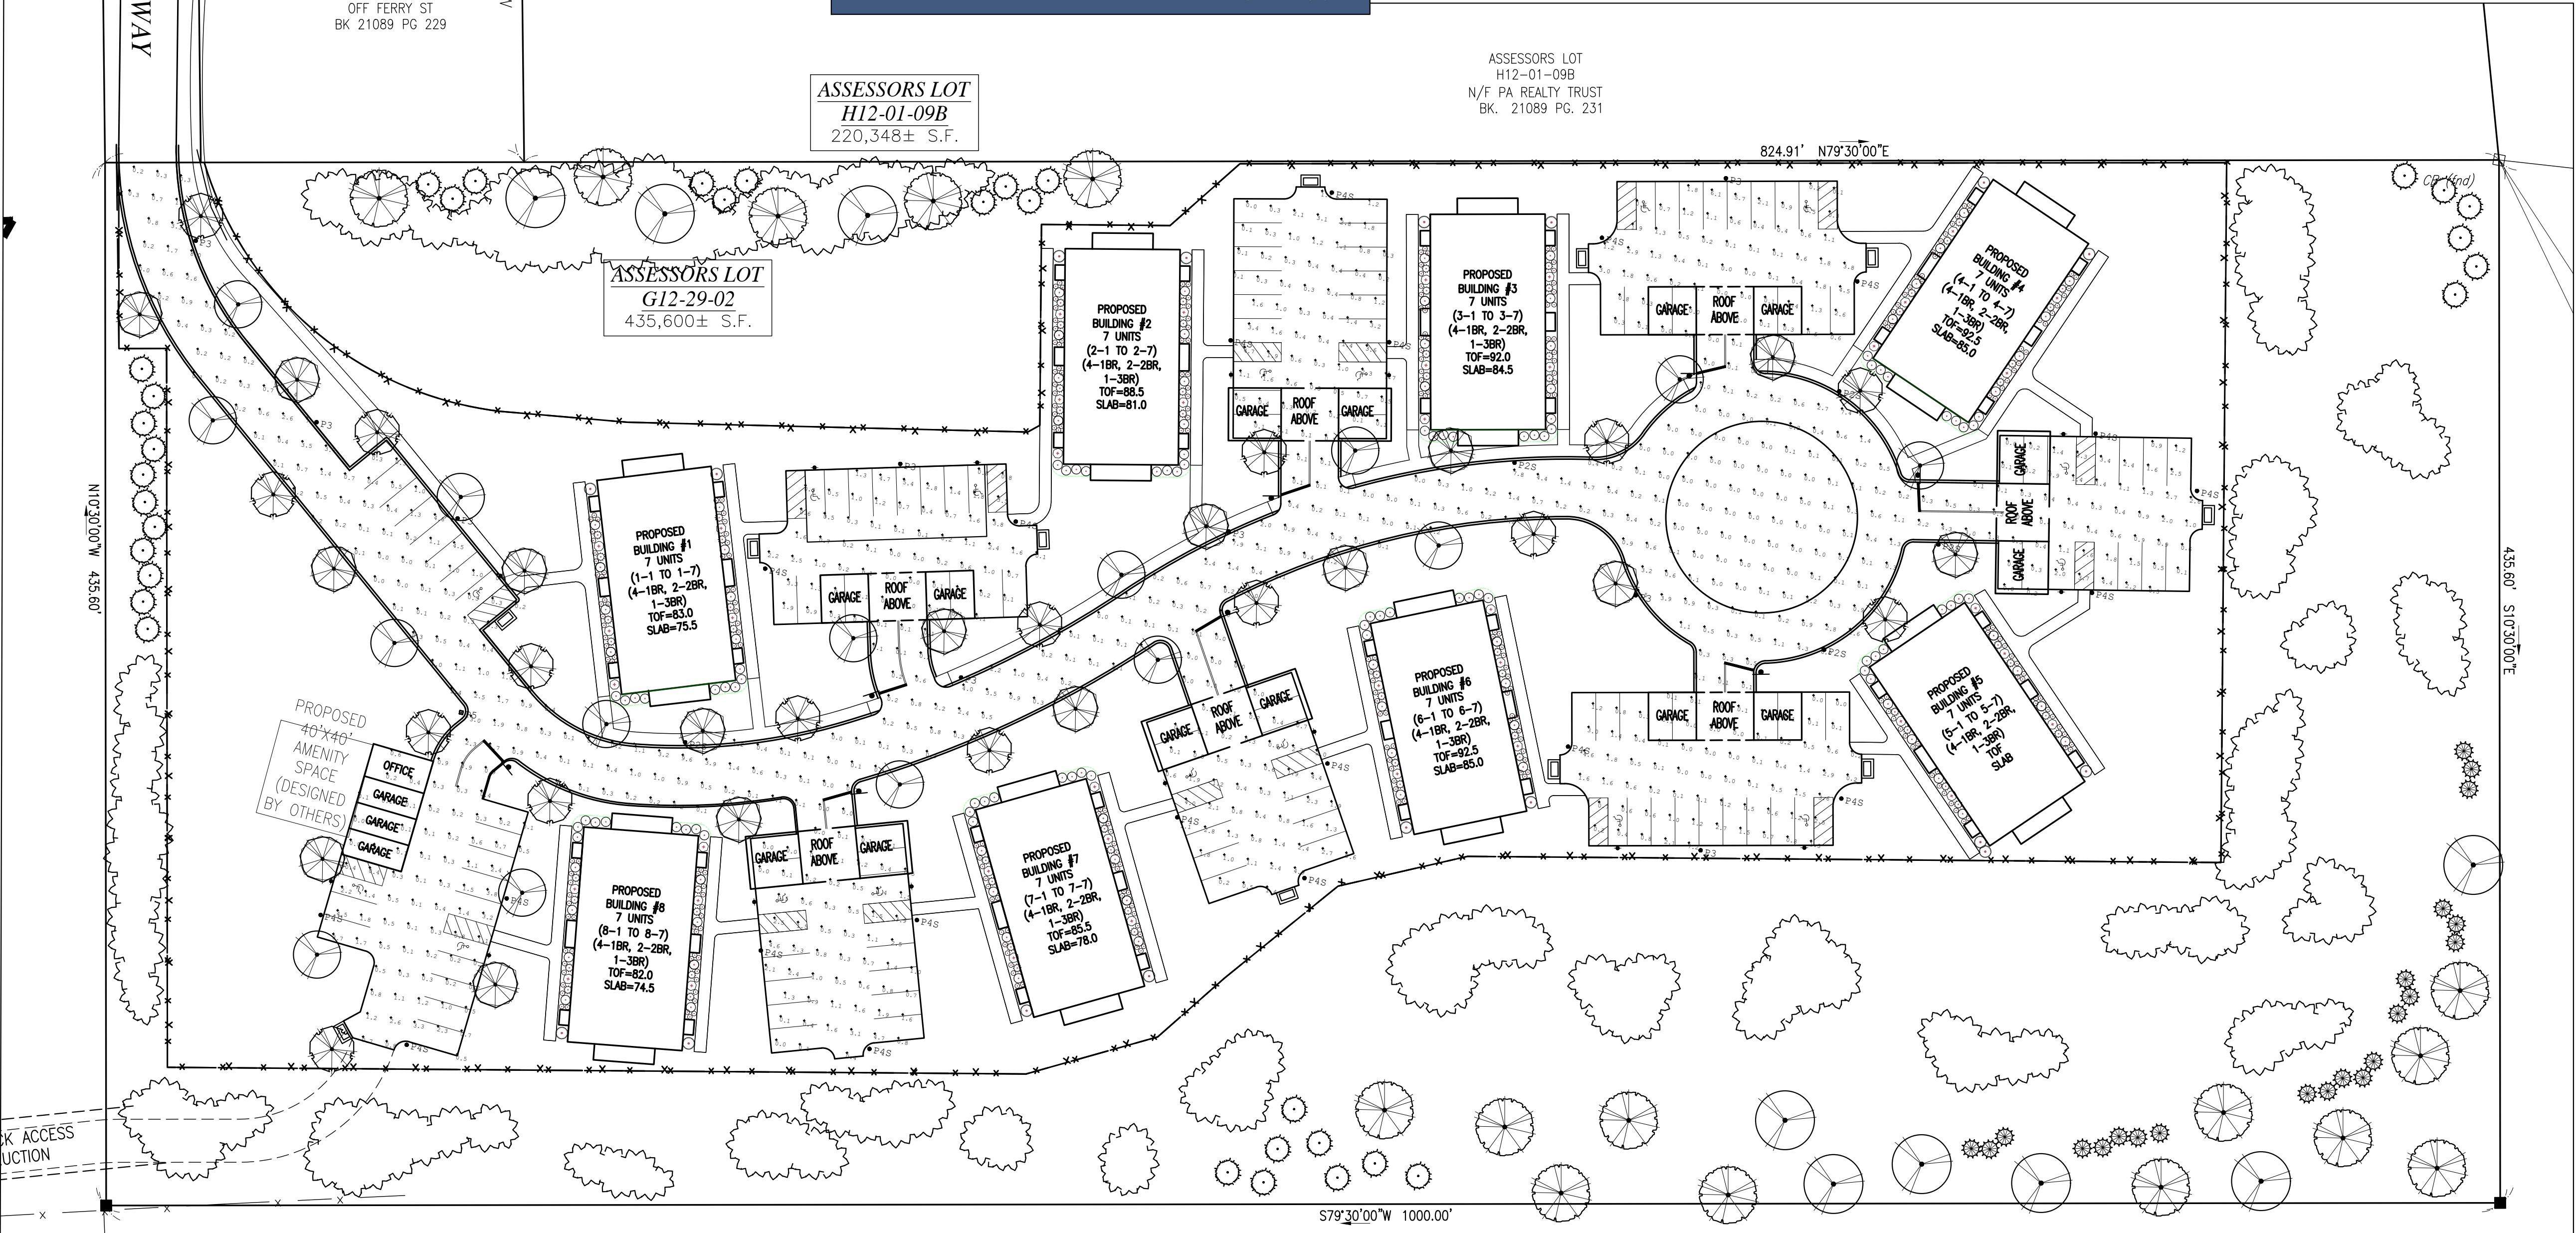

SITE PLAN
BRIDLE CROSSING
OFF FERRY STREET
MARSHFIELD, MASSACHUSETTS

PREPARED FOR:
MATLIN LLC C/O
KEVIN SEALUND & MATTHEW DACEY
794 WASHINGTON STREET
PEMBROKE, MA 02359

NOVEMBER 9, 2023
SCALE: AS SHOWN
JOB No. 12-243

GRADY CONSULTING, L.L.C.
Civil Engineers, Land Surveyors & Landscape Architects
71 Evergreen Street, Suite 1, Kingston, MA 02364
Phone (781) 585-2300